

NORTH



LEGEND

- RP NEW ROAD OWNER DIST. PILLAR.
- NEW STREET LIGHT CABLE - 0.6/1kV 2x1C 25 Sq mm Cu, XLPE/NJ/PVC & 1x1C 35 Sq mm Cu, PVC EARTH IN 80mm HD uPVC CONDUIT.
- E EXISTING POST MOUNTED STREET LIGHT.
- N NEW STREET LIGHT - 18W LED 'GE' EVOLVE LUMINAIRE (3000K LIGHT COLOUR TEMPERATURE) MOUNTED ON 6.5m POLE WITH 1.5m CURVED OUTREACH. SET BACK 1.1m FROM KERB.
- C/P NEW CABLE PIT (TYPE IN ACCORDANCE WITH PWC STD DWG S03-01-06-01).

PART SITE PLAN - AREA A (1:500 AT A1)


A	ISSUED FOR REVIEW	15-8-22	AG	AGA
No.	DESCRIPTION	DATE	INIT.	COMPANY.
AMENDMENTS				



GPO BOX 3097
DARWIN NT 0801
TELEPHONE: 08 89416582
FACSIMILE: 08 89421400
EMAIL: atekg@agaeng.com.au

DRAWN KT	CITY OF DARWIN
DATE AUG 22	
DESIGNED AG	
DATE AUG 22	
DATE	

BAYVIEW CONCEPT STREET LIGHTING STREET LIGHTING RETICULATION CONCEPT (SHEET 1 OF 2) & LEGEND			
SHEET No. SL01 OF 2	DRAWING No. SKSL01	AMENDMENT A	SHEET SIZE A1

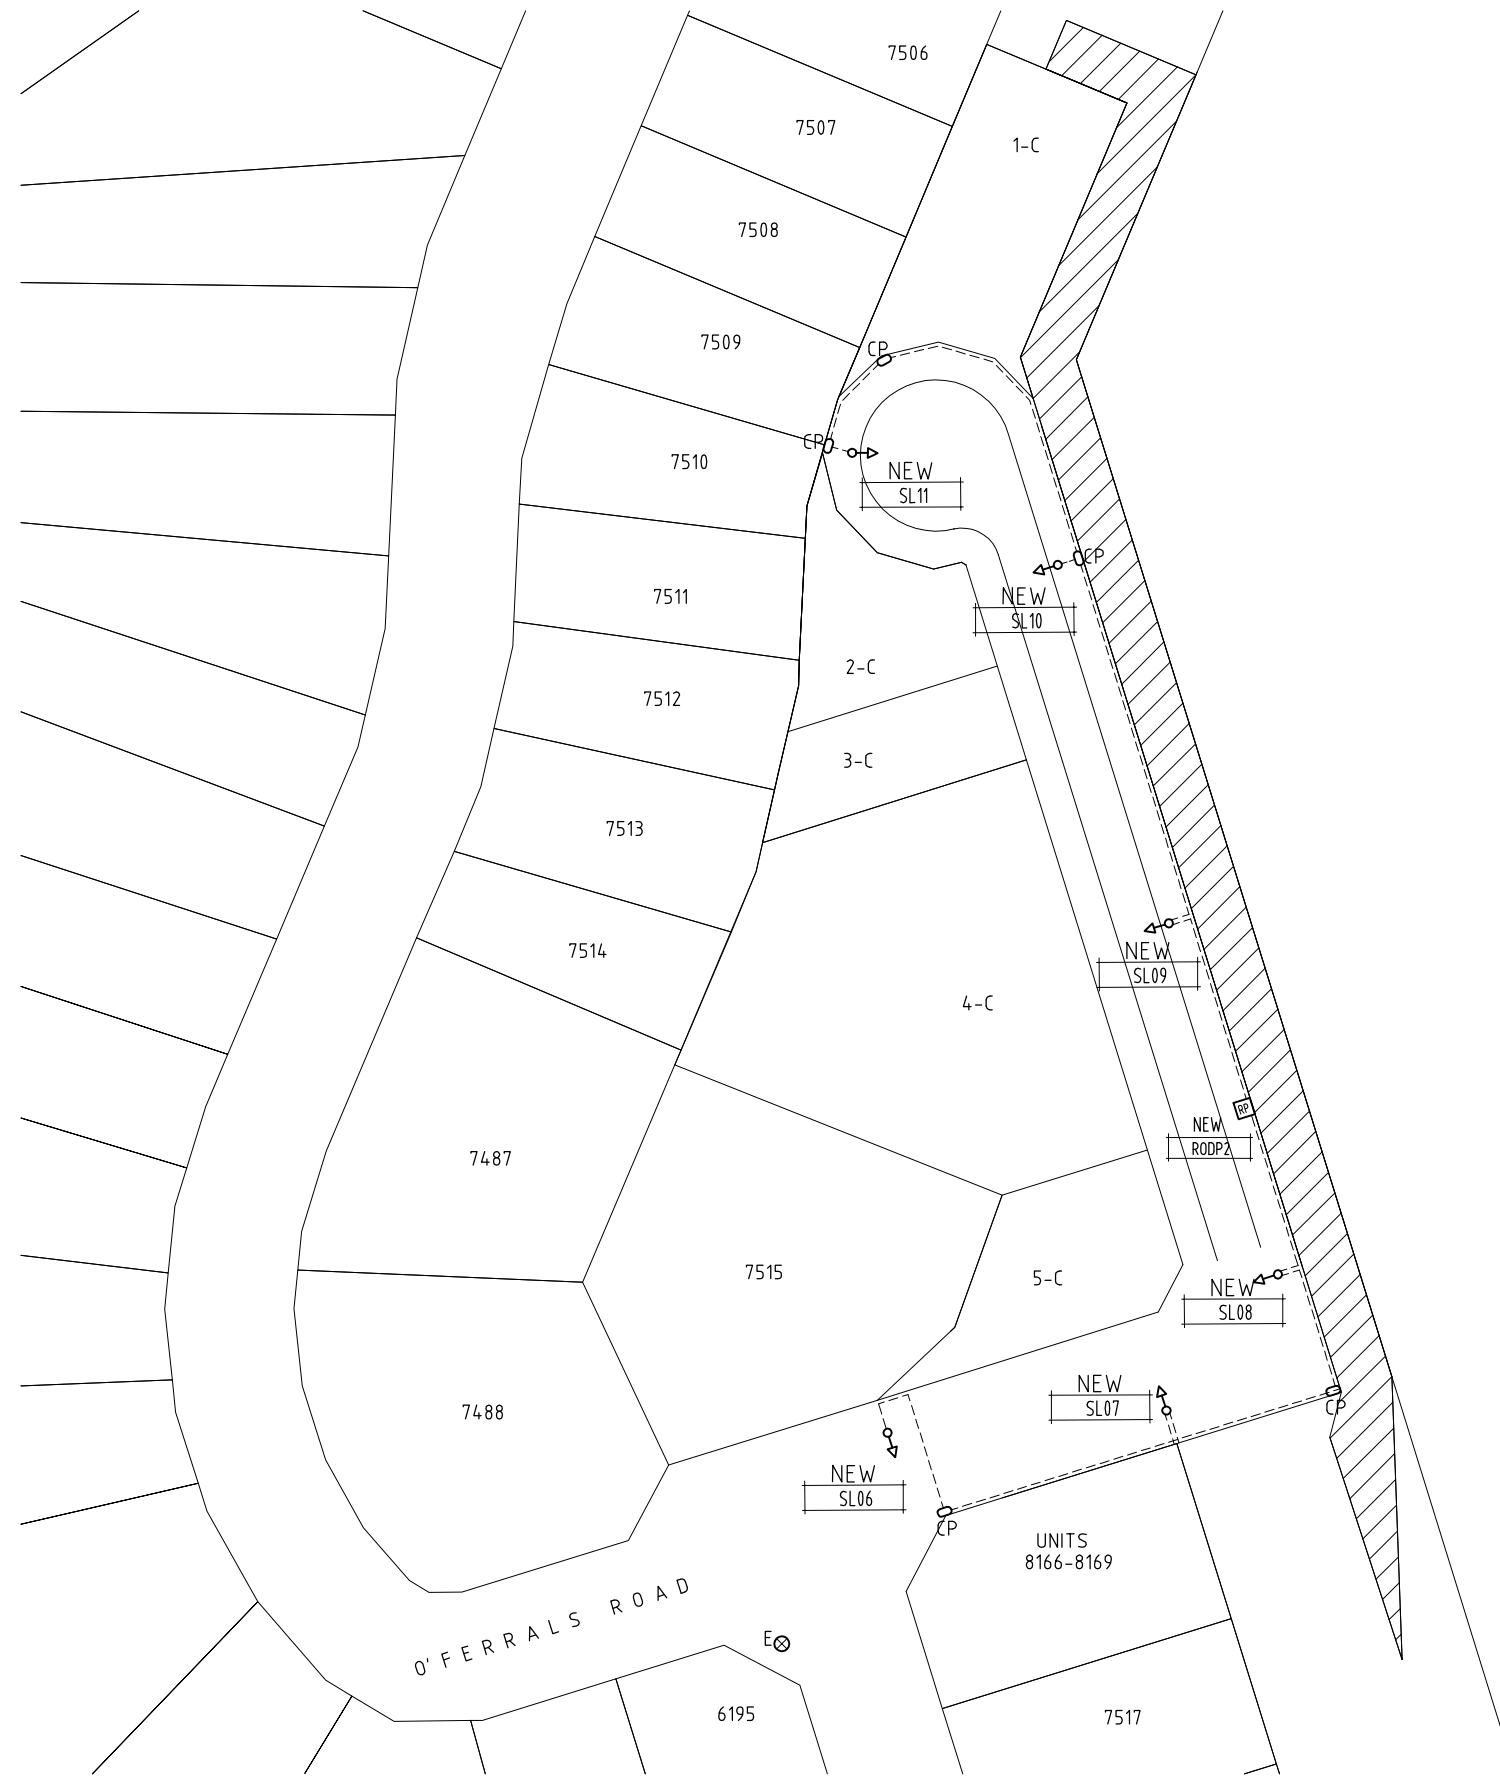

PART SITE PLAN - AREA B (1:500 AT A1)

No.	DESCRIPTION	DATE	INIT.	COMPANY.
A	ISSUED FOR REVIEW	15-8-22	AG	AGA
AMENDMENTS				



GPO BOX 3097
DARWIN NT 0801
TELEPHONE: 08 89416582
FACSIMILE: 08 89421400
EMAIL: atekg@agaeng.com.au

DRAWN
KT
DATE AUG 22
DESIGNED
AG
DATE AUG 22
DATE

CITY OF DARWIN

BAYVIEW
CONCEPT
STREET LIGHTING
STREET LIGHTING RETICULATION CONCEPT
(SHEET 2 OF 2)

SHEET No.	DRAWING No.	AMENDMENT	SHEET SIZE
SL02 OF 2	SKSL02	A	A1