

 
 
 





LEGEND

-  NEW ROAD OWNER DIST. PILLAR.
-  NEW STREET LIGHT CABLE - 0.6/1kV 2x1C 25 Sq mm Cu, XLPE/NJ/PVC & 1x1C 35 Sq mm Cu, PVC EARTH IN 80mm HD uPVC CONDUIT.
-  EXISTING POST MOUNTED STREET LIGHT.
-  NEW STREET LIGHT - 30W LED 'GE' EVOLVE LUMINAIRE (3000K LIGHT COLOUR TEMPERATURE) MOUNTED ON 6.5m POLE WITH 1.5m CURVED OUTREACH. SET BACK 1.1m FROM KERB.
-  NEW STREET LIGHT - 18W LED 'GE' EVOLVE LUMINAIRE (3000K LIGHT COLOUR TEMPERATURE) MOUNTED ON 6.5m POLE WITH 1.5m CURVED OUTREACH. SET BACK 1.1m FROM KERB.
-  NEW CABLE PIT (TYPE IN ACCORDANCE WITH PWC STD DWG S03-01-06-01).

PART SITE PLAN - AREA A (1:500 AT A1)

B A	RE-ISSUED FOR REVIEW	24-8-23	AG	AGA
	ISSUED FOR REVIEW	15-8-22	AG	AGA
No.	DESCRIPTION	DATE	INIT.	COMPANY.
AMENDMENTS				

 **AGA CONSULTING ENGINEERS PTY LTD**
ELECTRICAL & MECHANICAL
ACN 070 242 296

GPO BOX 3097
DARWIN NT 0801

TELEPHONE: 08 89416582
FACSIMILE: 08 89421400
EMAIL: alekg@agoeng.com.au

DRAWN
KT
DATE AUG 22

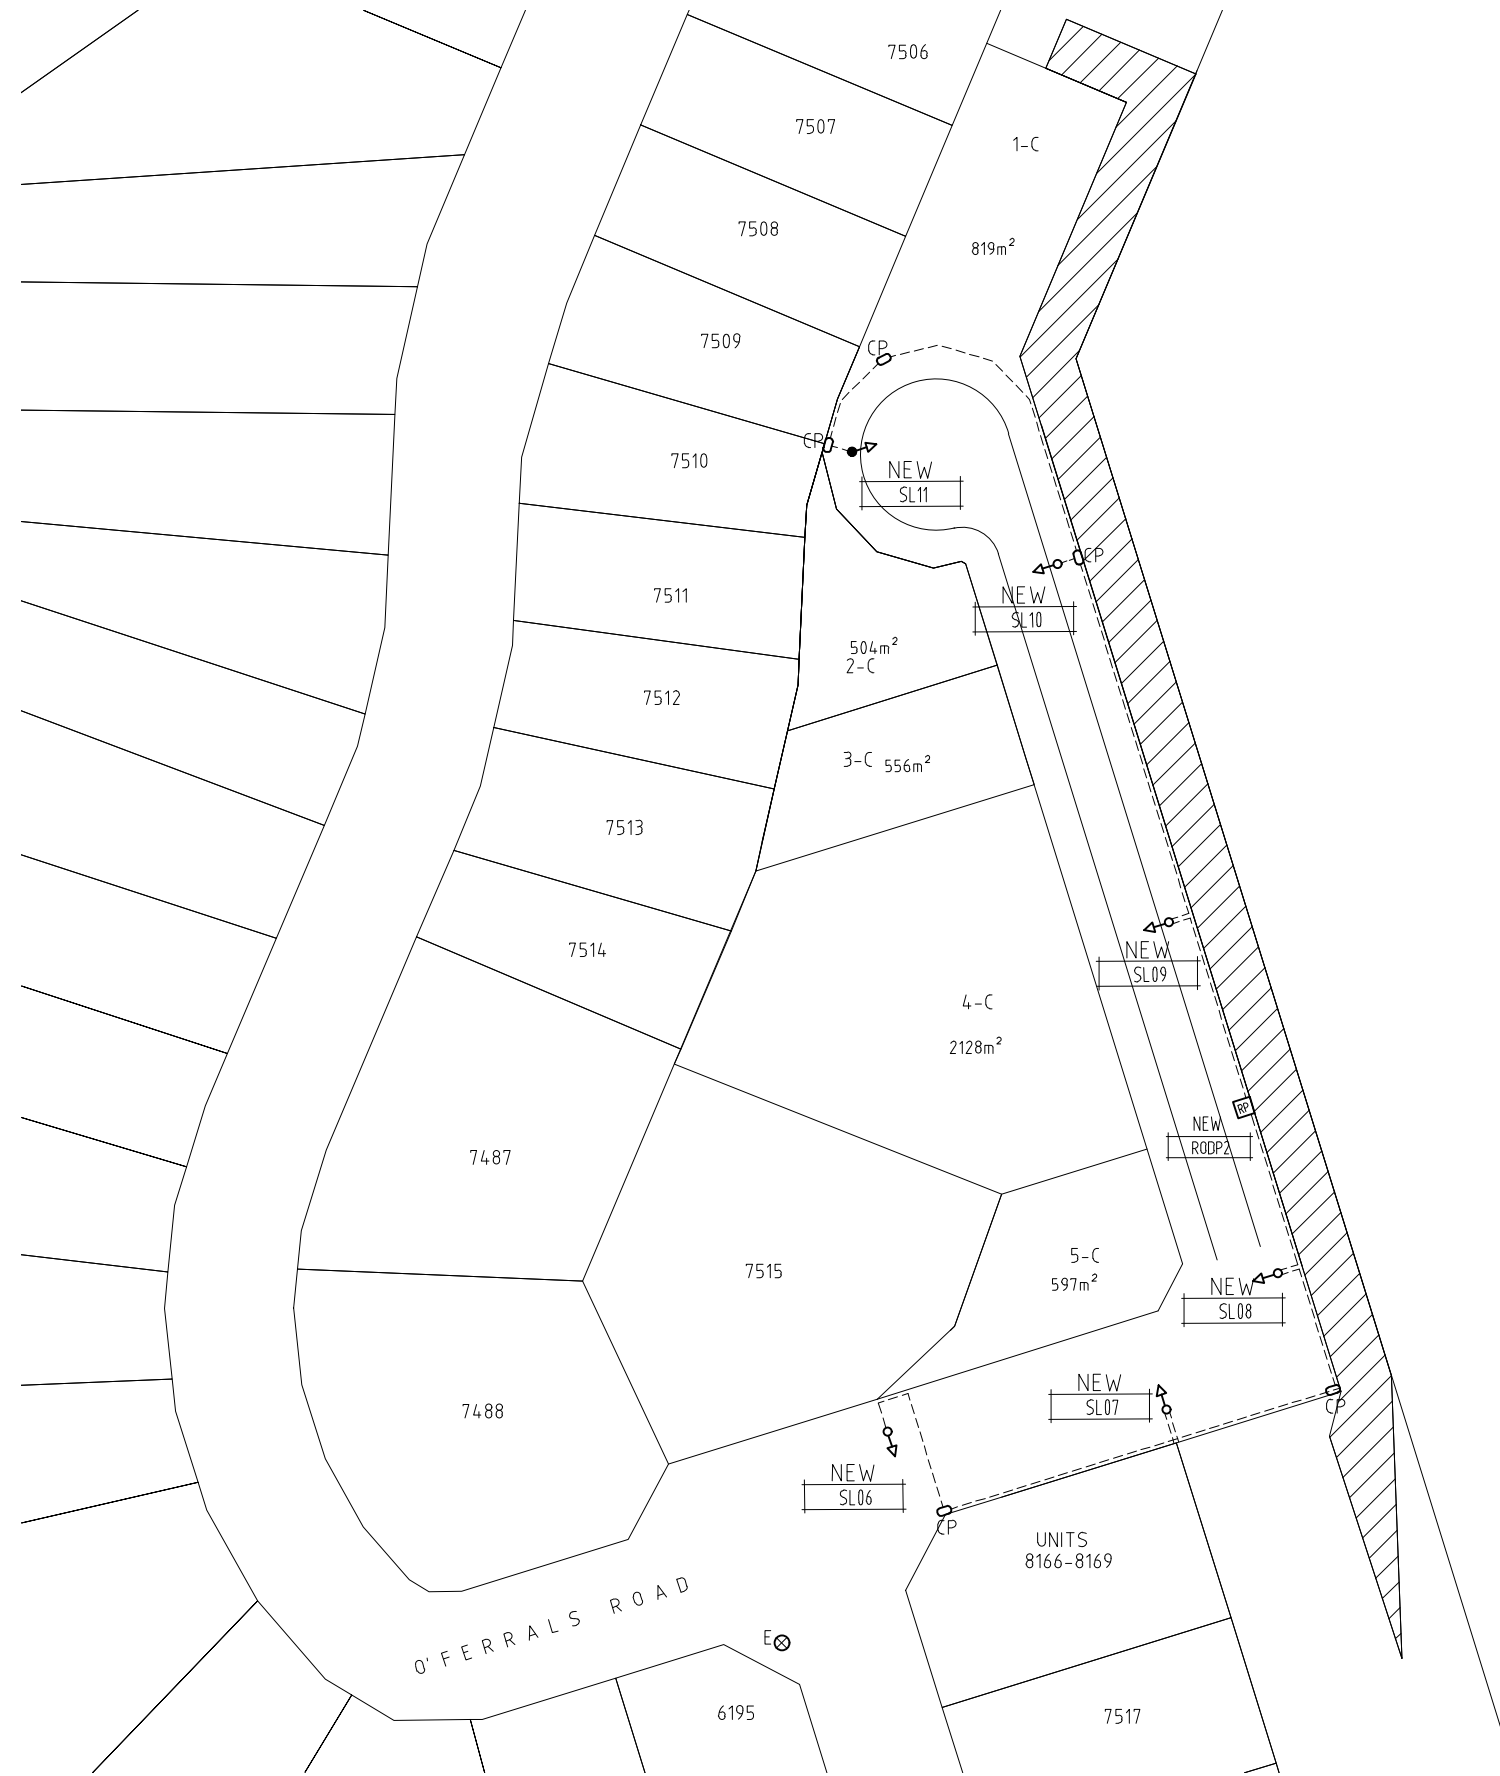
DESIGNED
AG
DATE AUG 22

DATE

CITY OF DARWIN

BAYVIEW
CONCEPT
**STREET LIGHTING
STREET LIGHTING RETICULATION CONCEPT
(SHEET 1 OF 2) & LEGEND**

-	-	SHEET No. SL01 OF 2	DRAWING No. SKSL01	AMENDMENT B	SHEET SIZE A1
---	---	------------------------	-----------------------	----------------	------------------



PART SITE PLAN - AREA B (1:500 AT A1)

B A	RE-ISSUED FOR REVIEW	24-8-23	AG	AGA
	ISSUED FOR REVIEW	15-8-22	AG	AGA
No.	DESCRIPTION	DATE	INIT.	COMPANY.
AMENDMENTS				



GPO BOX 3097
DARWIN NT 0801
TELEPHONE: 08 8946582
FACSIMILE: 08 89421400
EMAIL: alekg@agaeng.com.au

DRAWN	KT
DATE	AUG 22
DESIGNED	AG
DATE	AUG 22
DATE	

CITY OF DARWIN

BAYVIEW
CONCEPT
STREET LIGHTING
STREET LIGHTING RETICULATION CONCEPT
(SHEET 2 OF 2)

-	-	SHEET No. SL02 OF 2	DRAWING No. SKSL02	AMENDMENT B	SHEET SIZE A1
---	---	------------------------	-----------------------	----------------	------------------